


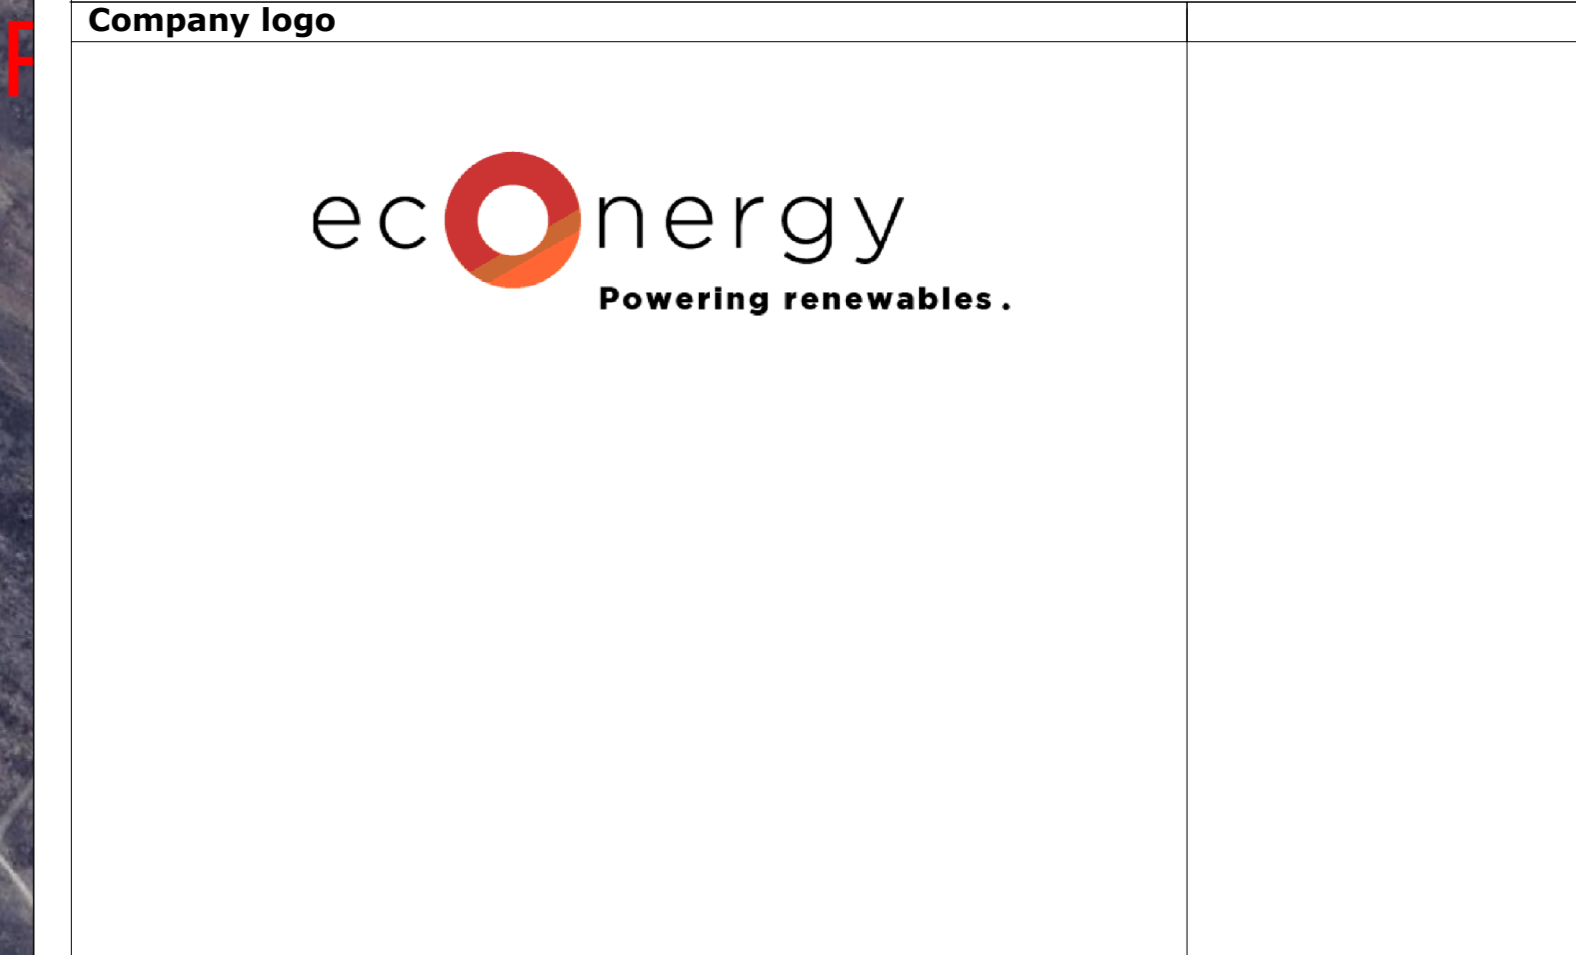

**PROJECT NAME:**  
Scurtu Mare PV Power Plant



SECTION		DRAWING CODE	
GENERAL		GENERAL LAYOUT	
<b>SHEET SIZE</b>	A1	<b>SCALE</b>	1:5000
		<b>FILE NAME</b>	
<b>REV</b>	<b>DATA</b>	<b>MODIFIED</b>	<b>DRAWN</b> <b>CHECKED</b> <b>APPROVED</b>
00	22-05-2023	Layout Boundary	G.C.
01			
02			
03			
04			
05			

All technical information contained in this document is the exclusive property of Ecenergy and may not be used for any other purpose without its prior written consent.